


2020 STREET IMPROVEMENT PROJECT

DODGE CENTER, MINNESOTA

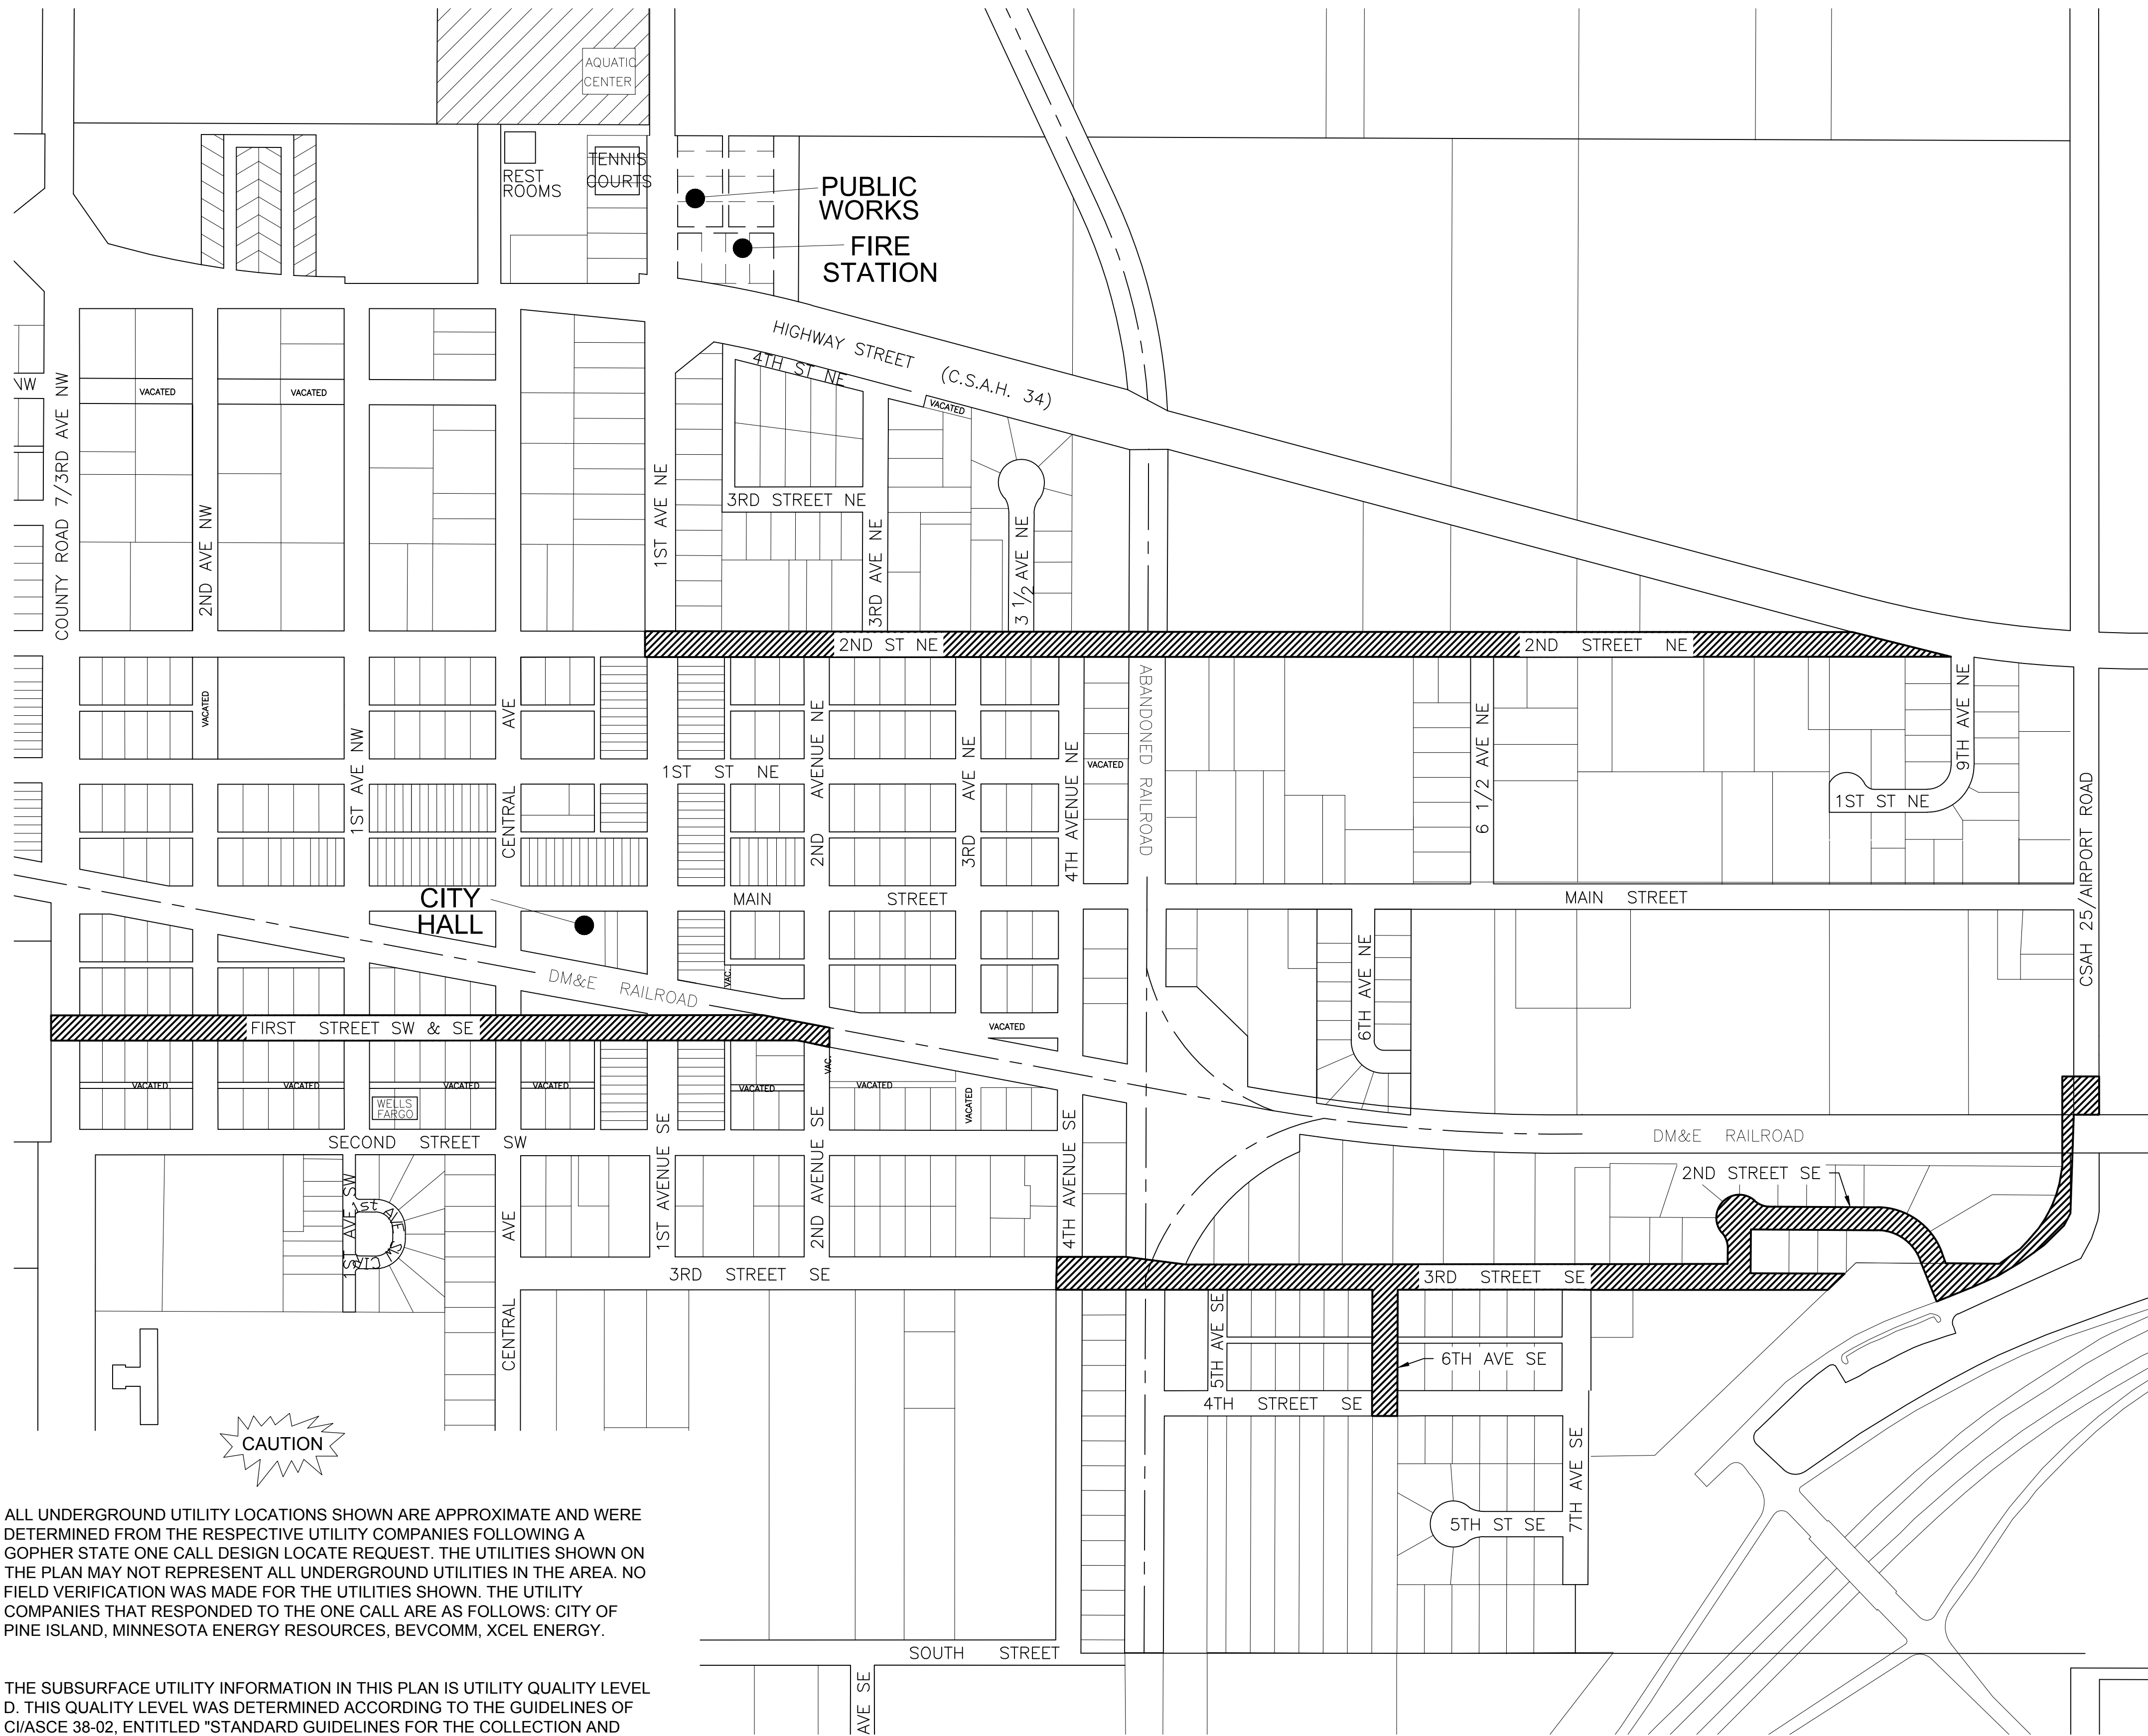

GOVERNING SPECIFICATIONS

THE 2018 EDITION OF THE MINNESOTA DEPARTMENT OF TRANSPORTATION
"STANDARD SPECIFICATIONS FOR CONSTRUCTION" SHALL GOVERN.


INDEX	
SHEET	DESCRIPTION
1	TITLE SHEET
2	LEGEND
3 - 4	STATEMENT OF ESTIMATED QUANTITIES
5	CONSTRUCTION NOTES & STANDARD PLATES
6	WATER SERVICE SCHEDULE
7 - 8	STORM SEWER SCHEDULE
9 - 10	SIGN TABULATION
11 - 12	STANDARD DETAILS
13 - 14	TYPICAL SECTIONS
15 - 20	STANDARD PLANS
21 - 28	SIGNING PLAN
29	TRAFFIC CONTROL PLAN
30 - 38	REMOVALS PLAN
39 - 48	EROSION CONTROL PLAN
49 - 50	SWPPP NARRATIVE
51 - 56	PLAN & PROFILE - 2ND STREET NE
57	BOX CULVERT ELEVATION - 2ND STREET NE
58 - 61	PLAN & PROFILE - 1ST STREET SW & SE
62 - 65	PLAN & PROFILE - 3RD STREET SE
66 - 67	PLAN & PROFILE - 2ND STREET SE
68	PLAN & PROFILE - 6TH AVENUE SE
69 - 70	PLAN & PROFILE - AIRPORT DRIVE WATERMAIN EXTENSION
71	POND GRADING PLAN
72	POND DETAILS
73 - 117	CROSS SECTIONS

* THIS PLAN CONTAINS 117 SHEETS

CITY OFFICIALS

MAYOR: BILL KETCHUM
 COUNCIL MEMBERS: GARY TRELSTAD, PAUL BLAISDELL, CATHY SKOGEN, MATT MAAS
 CITY ADMINISTRATOR: JOSHUA TETZLAFF
 MAINTENANCE SUPERINTENDENT: MARK BARWALD

PROJECT LOCATIONS

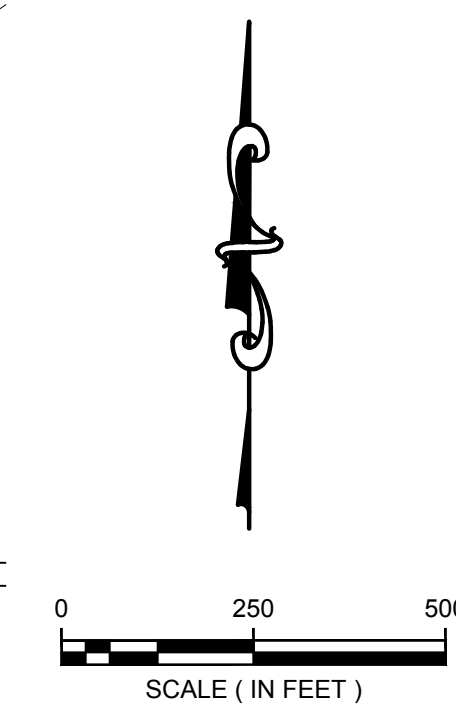

ALL UNDERGROUND UTILITY LOCATIONS SHOWN ARE APPROXIMATE AND WERE DETERMINED FROM THE RESPECTIVE UTILITY COMPANIES FOLLOWING A GOPHER STATE ONE CALL DESIGN LOCATE REQUEST. THE UTILITIES SHOWN ON THE PLAN MAY NOT REPRESENT ALL UNDERGROUND UTILITIES IN THE AREA. NO FIELD VERIFICATION WAS MADE FOR THE UTILITIES SHOWN. THE UTILITY COMPANIES THAT RESPONDED TO THE ONE CALL ARE AS FOLLOWS: CITY OF PINE ISLAND, MINNESOTA ENERGY RESOURCES, BEVCOMM, XCEL ENERGY.

THE SUBSURFACE UTILITY INFORMATION IN THIS PLAN IS UTILITY QUALITY LEVEL D. THIS QUALITY LEVEL WAS DETERMINED ACCORDING TO THE GUIDELINES OF C/ASCE 38-02, ENTITLED "STANDARD GUIDELINES FOR THE COLLECTION AND DEPICTION OF EXISTING SUBSURFACE UTILITY DATA".



WIDSETH SMITH NOLTING
 Engineering | Architecture | Surveying | Environmental

DATE: MARCH, 2020
 SCALE: AS SHOWN
 DRAWN BY: BRB
 CHECKED BY: CNB
 JOB NUMBER: 1009R0023

BY: _____
 REVISIONS DESCRIPTION: _____
 DATE: _____

2020 STREET IMPROVEMENT PROJECT
 CITY OF DODGE CENTER
 DODGE CENTER, MINNESOTA
TITLE SHEET

SHEET NO.
1